

KITCHEN- CABINETRY SPECIFICATIONS			
CONSTRUCTION		FINISH	
FRAME:	FRAMELESS	FASCIA MATERIAL:	PAINT GRADE MAPLE
DOOR STYLE:	1" T STEPPED & REFECTORY	EXTERIOR FINISH:	BASE COAT (TBD) - ON SITE GLAZE
DOOR STILE/RAIL:	5/8" & 2"	INTERIOR MATERIAL:	NATURAL MAPLE
DRAWER STYLE:	1" T STEPPED	INTERIOR FINISH:	CLEAR
DWR STILE/RAIL:	5/8"	GLASS CAB. INTERIOR:	PAINTED TO MATCH EXTERIOR
PANEL STYLE:	1" T PLAIN & REFECTORY	OPEN CAB. INTERIOR:	N/A
HINGE/CATCH FINISH:	CONCEALED EURO	GRILLE CAB. INTERIOR:	N/A
INTERIOR LIGHTING:	YES	OTHER:	N/A
	(FIXTURES PROVIDED BY CLIENT)		
MOULDINGS		HEIGHTS	
ASTRAGAL BEAD:	N/A	FINISHED CABINET HT:	110"H (INCLUDING CROWN)
CROWN MOULDING:	3"H STEPPED FASCIA	CROWN:	3"H STEPPED FASCIA
FASCIA MOULDING:	N/A	BASE CABINET:	34 1/2" HIGH
BASE MOULDING:	N/A	WALL CABINET:	51 3/4" HIGH
DECORATIVE:	N/A	WORKTOP CABINET:	71 1/4" HIGH
		TALL CABINET:	107" HIGH
		WALL/TOP RAIL:	N/A
		RECESSED TOE KICK:	4" HIGH

KITCHEN - ROOM DIMENSIONS (FINISHED)	
FINISHED CEILING HEIGHT:	110"H A.F.F.
CASINGS (Wx TH):	*VERIFY*
ROOM CROWN (O.A. HT):	N/A
ROOM BASE (Wx HT):	*VERIFY*
WINDOW HEIGHT:	N/A
WINDOW SILL HEIGHT:	N/A
DOOR HEADER HEIGHT:	94 1/4" HIGH

KITCHEN - APPLIANCE & PLUMBING SCHEDULE									
SYM.	APPLIANCE	MANUFACTURER	MODEL #	FINISH	O/A SIZE W x H x D	CUT-OUT W x H x D	SUPPLIED BY	INSTALLED BY	NOTES
A	MAIN KITCHEN	KOHLER	K-5416						
B	MAIN FAUCET	*VERIFY*	*VERIFY*						
C	DISPOSAL	*VERIFY*	*VERIFY*						
D	DISHWASHER - EXISTING	BOSCH	*VERIFY*	S/S					
E	36" COOKTOP	WOLF	*VERIFY*						
F	HOOD INSERT	*VERIFY*	*VERIFY*						
G	36" REF/FREEZER - EXISTING	SUBZERO	BI-36U/S/TH-LH	S/S					
H	30" DOUBLE OVEN - EXISTING	WOLF	DO30F/S	S/S					
I	30" MICRO DRAWER	WOLF	*VERIFY*						
J									

KITCHEN - HARDWARE SCHEDULE

SYM.	DESCRIPTION	MANUFACTURER	MODEL #	QTY.	EXTRA	ORDERDED	FINISH	REMARKS
1								
2								
3								
4								
5								
6								
7								
8								

1" T DOOR

1" B BUMPER

CARCASS

1 1/2" H RAIL #38 (TO CONCEAL LIGHTING)

1/8" REVEAL


#36

1" BLOCKING

1 1/8" 1"

3CM
COUNTERTOP
THICKNESS

1"
COUNTERTOP
OVERHANG

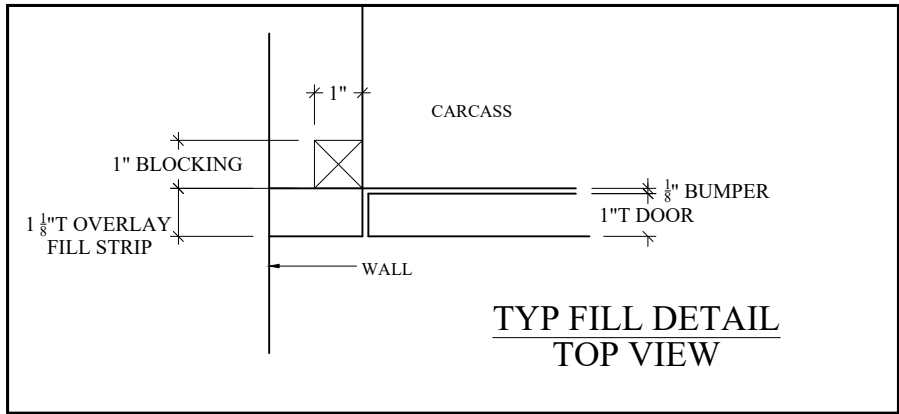

Doe Residence
000 N Lakeshore Dr
Unit XXX
Chicago, IL 60654

Kitchen

GENERAL NOTES:

REVISIONS

[illegible]

Disclaimer

CEILING LEVELS: Should these drawings indicate cabinetry installed to the ceiling, it is assumed that the ceiling will be level and true at the time of cabinet installation. If the ceiling level varies, we cannot accept responsibility for any open space between the top of the cabinetry trim to the ceiling. The finish trim or cabinet crown moulding will be attached to the cabinetry, leveled, and set to the lowest part of the ceiling. Any further remedy is the responsibility of the client or the client's representative.

APPLIANCES: This contract does not include the installation or setting into place of any appliances. The appliance installation is the sole responsibility of the client or the client's representative. Appliances must be on site at the time of the installation, at which time, all panels will be applied. Should appliances not be on site, additional charges may be applied for return visits.



Designer: Elizabeth Haar

Drawn By: Elizabeth Haan

Project #: 19-004

Client Approval Signature:

DRAWING SCALE: 1/2"=1'-0"

SHEET: 1 OF 3

Doe Residence
000 N Lakeshore Dr
Unit XXX
Chicago, IL 60654

Kitchen

GENERAL NOTES:

REVISIONS

[illegible]

Disclaimer

CILING LEVELS: Should these drawings indicate cabinetry installed to ceiling, it is assumed that the ceiling will be level and true at the time of cabinet installation. If the ceiling level varies, we cannot accept responsibility for any open space between the top of the cabinetry trim to the ceiling. The finish trim or cabinet crown moulding will be attached to the cabinetry, leveled, and set to the lowest part of the ceiling. Any further remedy is the responsibility of the client or the client's representative.

APPLIANCES: This contract does not include the installation or setting into place of any appliances. The appliance installation is the sole responsibility of the client or the client's representative. Appliances must be on site at the time of the installation, at which time, all panels will be applied. Should appliances not be on site, additional charges may be applied for return visits.



Designer: Elizabeth Haar



Drawn By: Elizabeth Haar

Project #: 19-004

Client Approval Signature:

DRAWING SCALE: 1/2"=1'-0"

SHEET: 2 OF 3

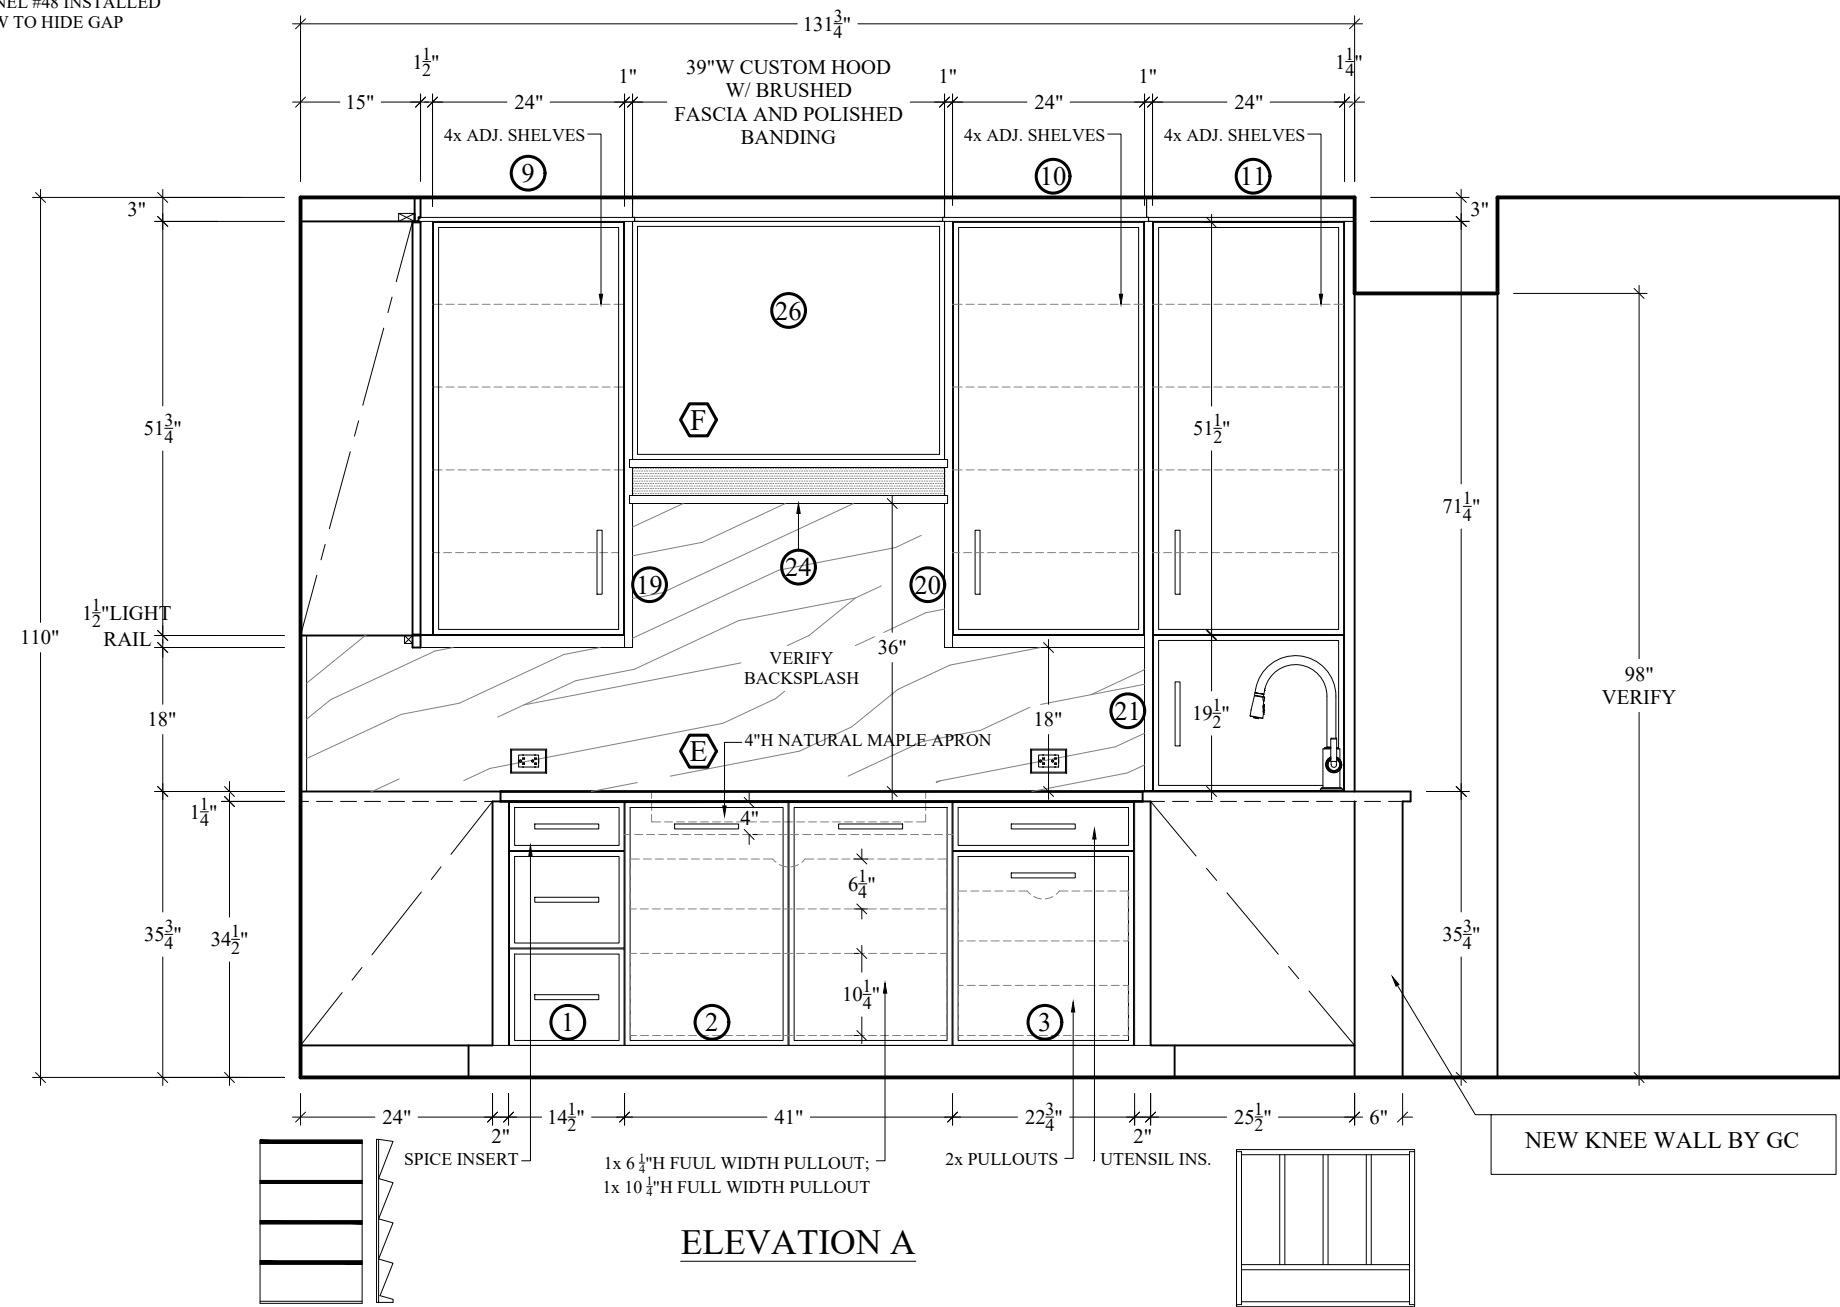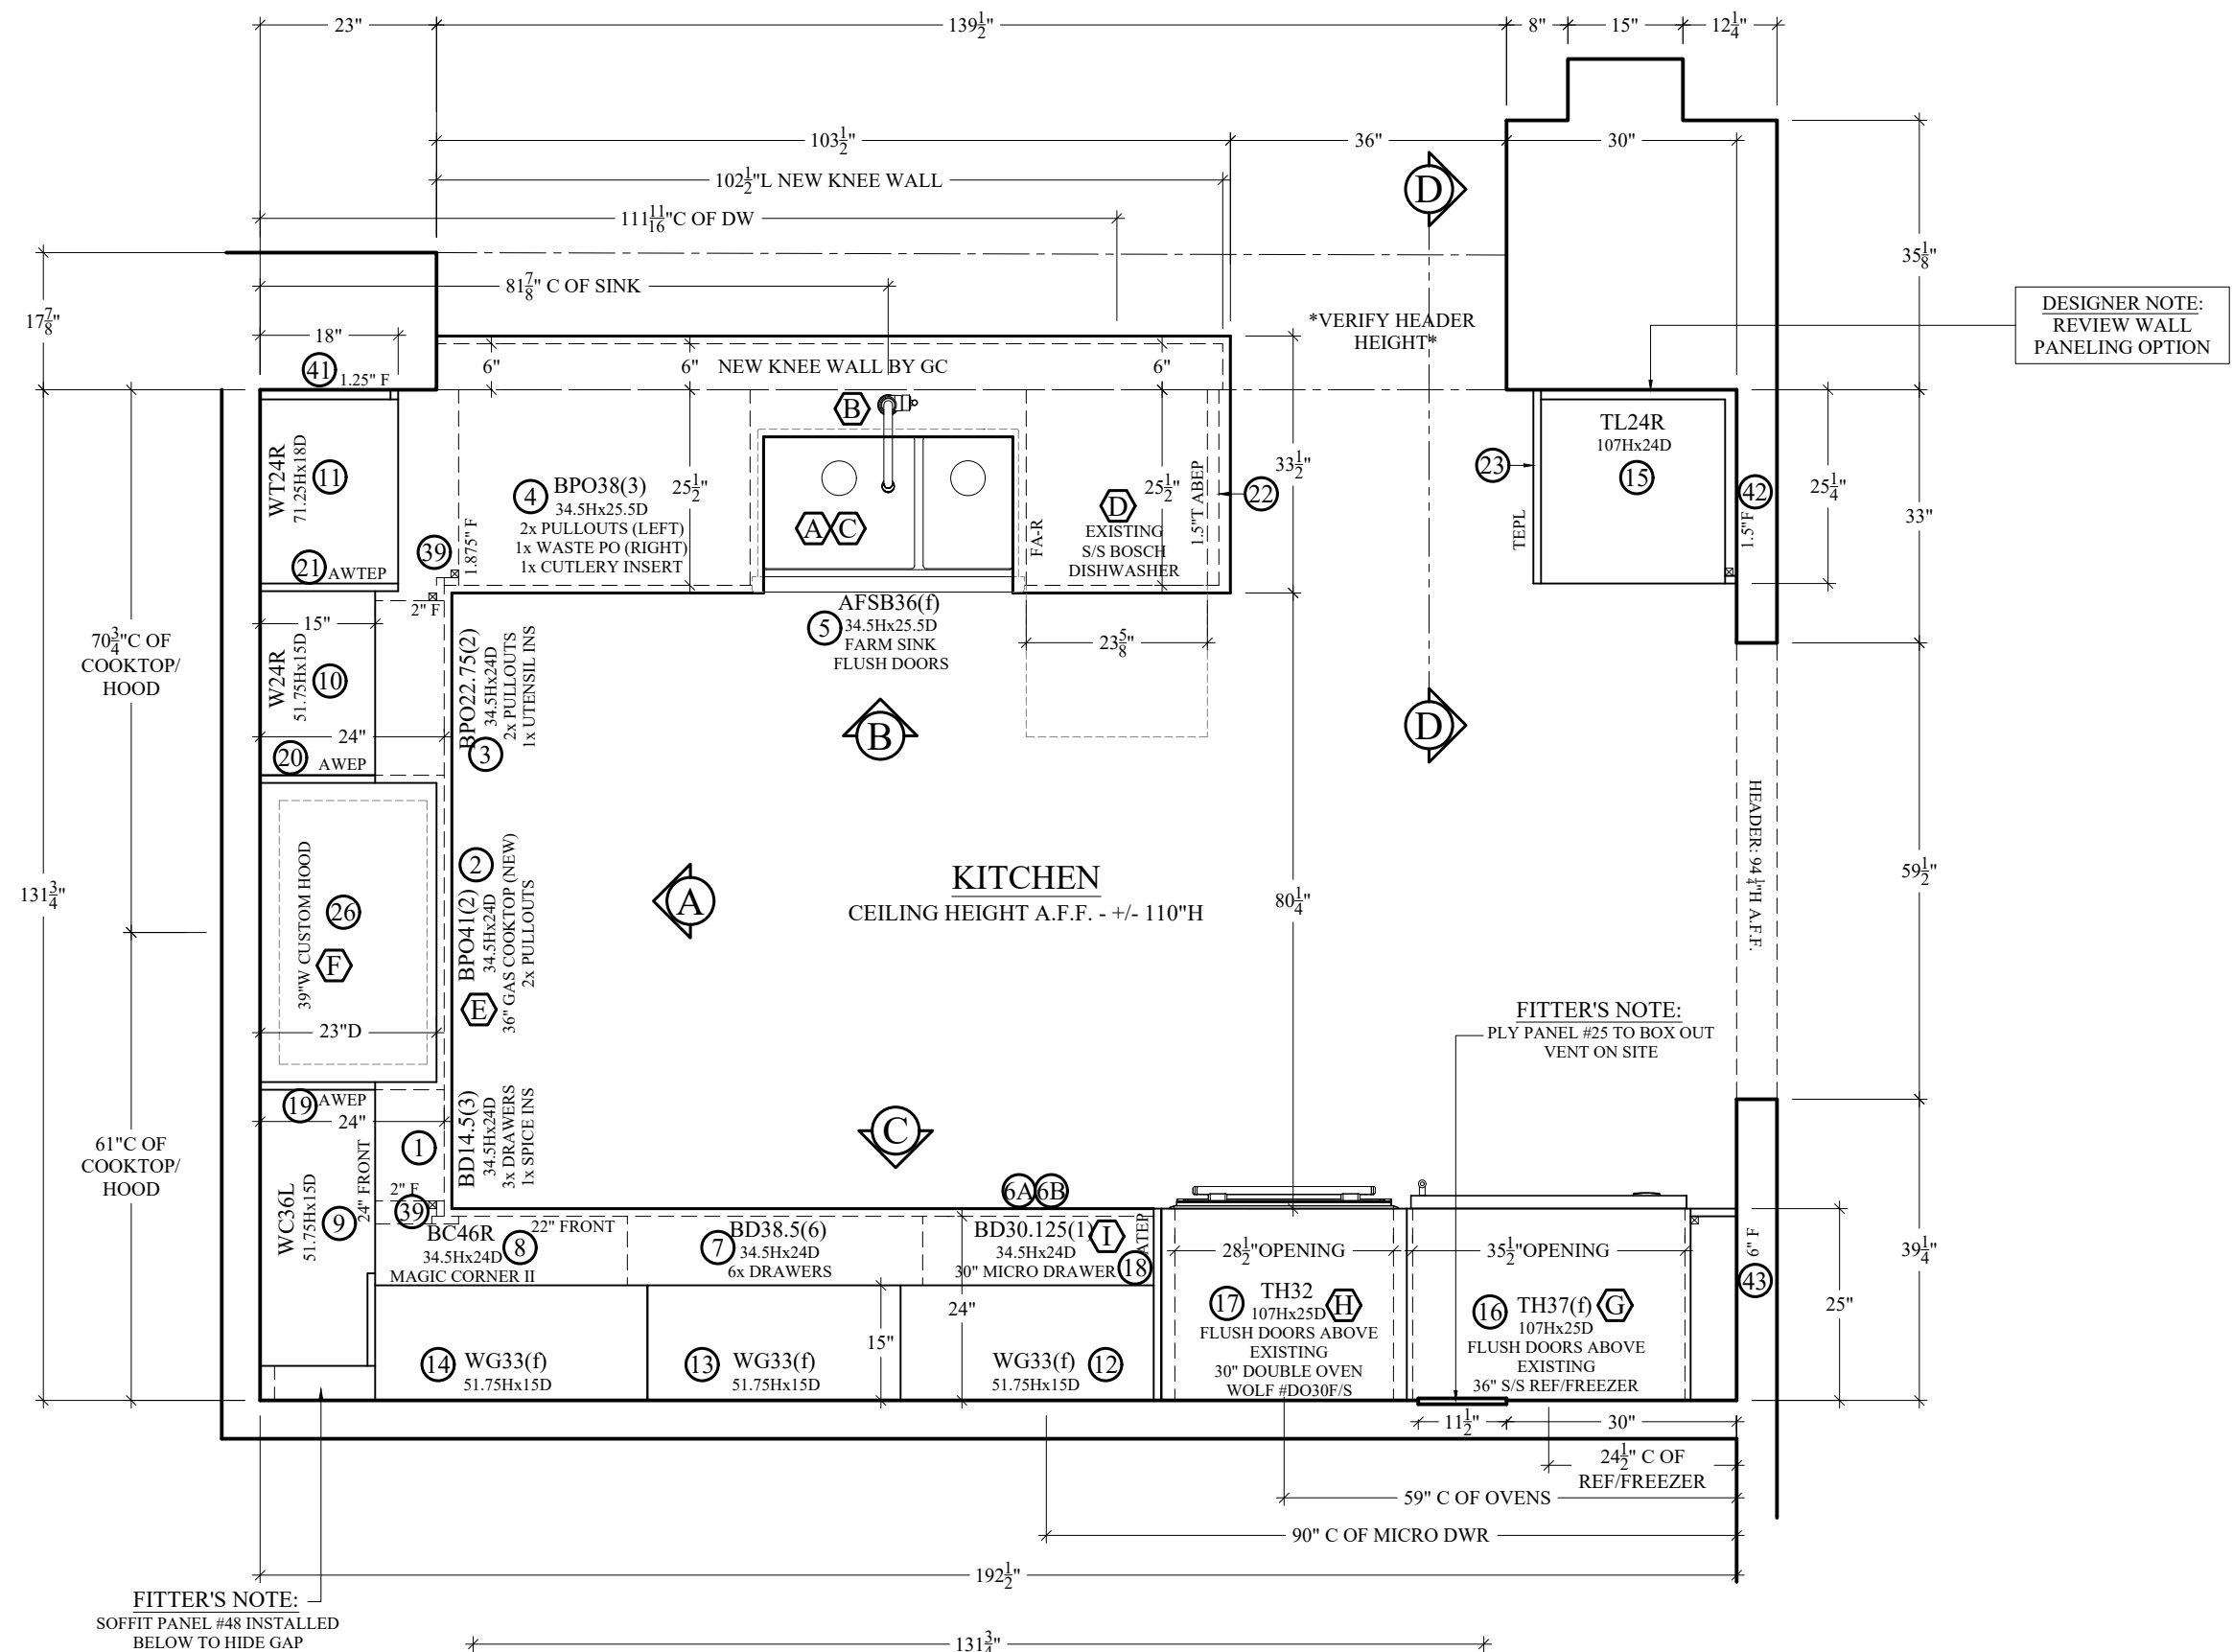

Doe Residence
000 N Lakeshore Dr
Unit XXX
Chicago, IL 60654

Kitchen

GENERAL NOTES:	

[illegible]

Disclaimer

CILING LEVELS: Should these drawings indicate cabinetry installation to the ceiling, it is assumed that the ceiling will be level and true at the time of cabinet installation. If the ceiling level varies, the contractor cannot be held responsible for the leveling of the cabinetry trim to the ceiling. The finish trim or cabinet crown moulding will be attached to the cabinetry, leveled, and set to the lowest part of the ceiling. Any further remedy is the responsibility of the client or the client's representative.

APPLIANCES: This contract does not include the installation or setting into place of any appliances. The appliance installation is the sole responsibility of the client's representative.

Appliances must be on site at the time of the installation, at which time, all panels will be applied. Should appliances not be on site, additional charges may be applied for return visits.



Designer: Elizabeth Haar

Drawn By: Elizabeth Haar

Project #: 19-004

Client Approval Signature:

DRAWING SCALE: 1/2"=1'-0"

SHEET: 3 OF 3

